

LAKESIDE OF CHESHIRE

Drawn By:
 Checked By:
 Date: 5/19/2020

 
 

Scale:

Revisions


| # | Date | Comments |
|---|------|----------|
| | | |
| | | |
| | | |




LANGLAIS GROUP INC.
 P.O. BOX 696 ROAD
 SOUTH WINDSOR CT 06074
 PHONE 860-289-2372
 FAX 860-566-2460

| Luminaire Schedule | | | | |
|---|-----|-----------|-------------|--|
| Symbol | Qty | Label | Arrangement | Description |
|  | 6 | T4-9L | SINGLE | LED-ARL-150W-40K-IV-SA-BMS(FIELD TUNED TO 73 WATTS MH 12') |
|  | 7 | T4-9L-DBL | BACK-BACK | (2) LED-ARL-150W-40K-IV-SA-BMS(FIELD TUNED TO 73 WATTS MH 12') |
|  | 30 | T3-9L | SINGLE | LED-ARL-150W-40K-III-SA-BMS(FIELD TUNED TO 73 WATTS MH 12') |

| Calculation Summary | | | | | | | |
|---------------------|-------------|-------|------|------|-----|---------|---------|
| Label | CalcType | Units | Avg | Max | Min | Avg/Min | Max/Min |
| CALC GRID_Planar | Illuminance | Fc | 1.07 | 12.8 | 0.0 | N.A. | N.A. |
| PAVED AREA | Illuminance | Fc | 3.10 | 12.8 | 0.5 | 6.20 | 25.60 |

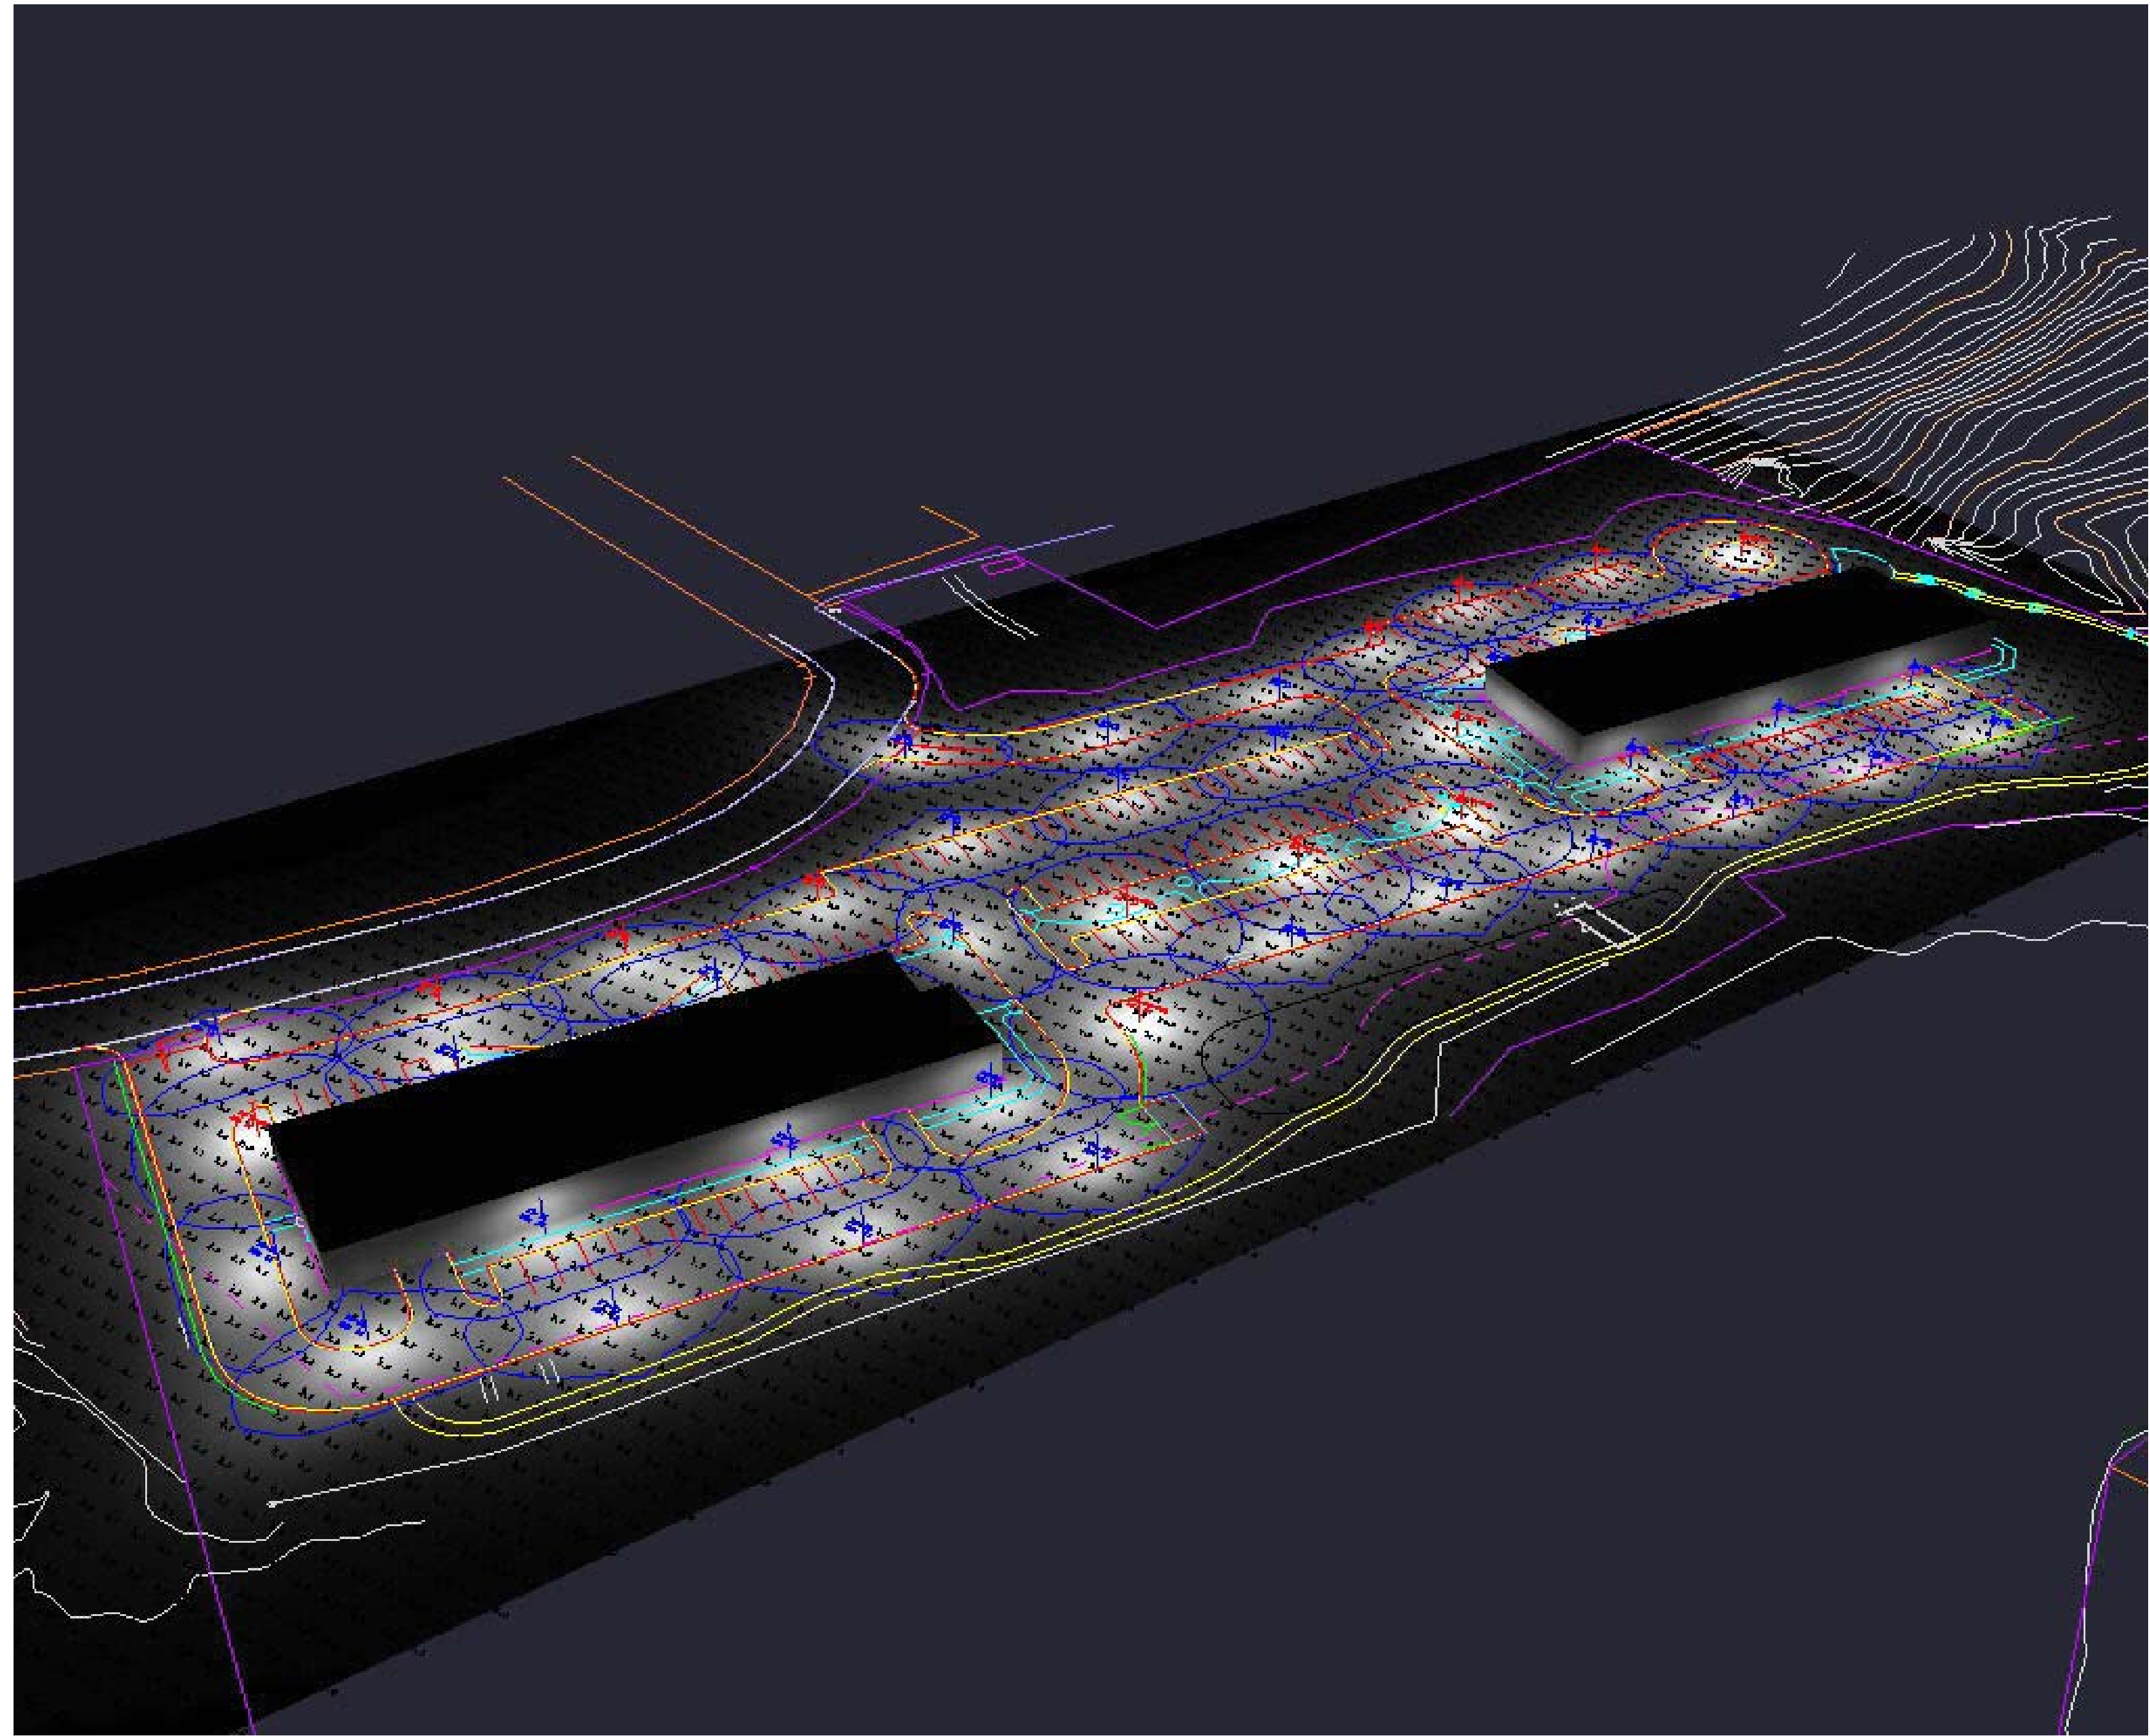

<InsertImage_RenderView_1>{VIEWNAME}

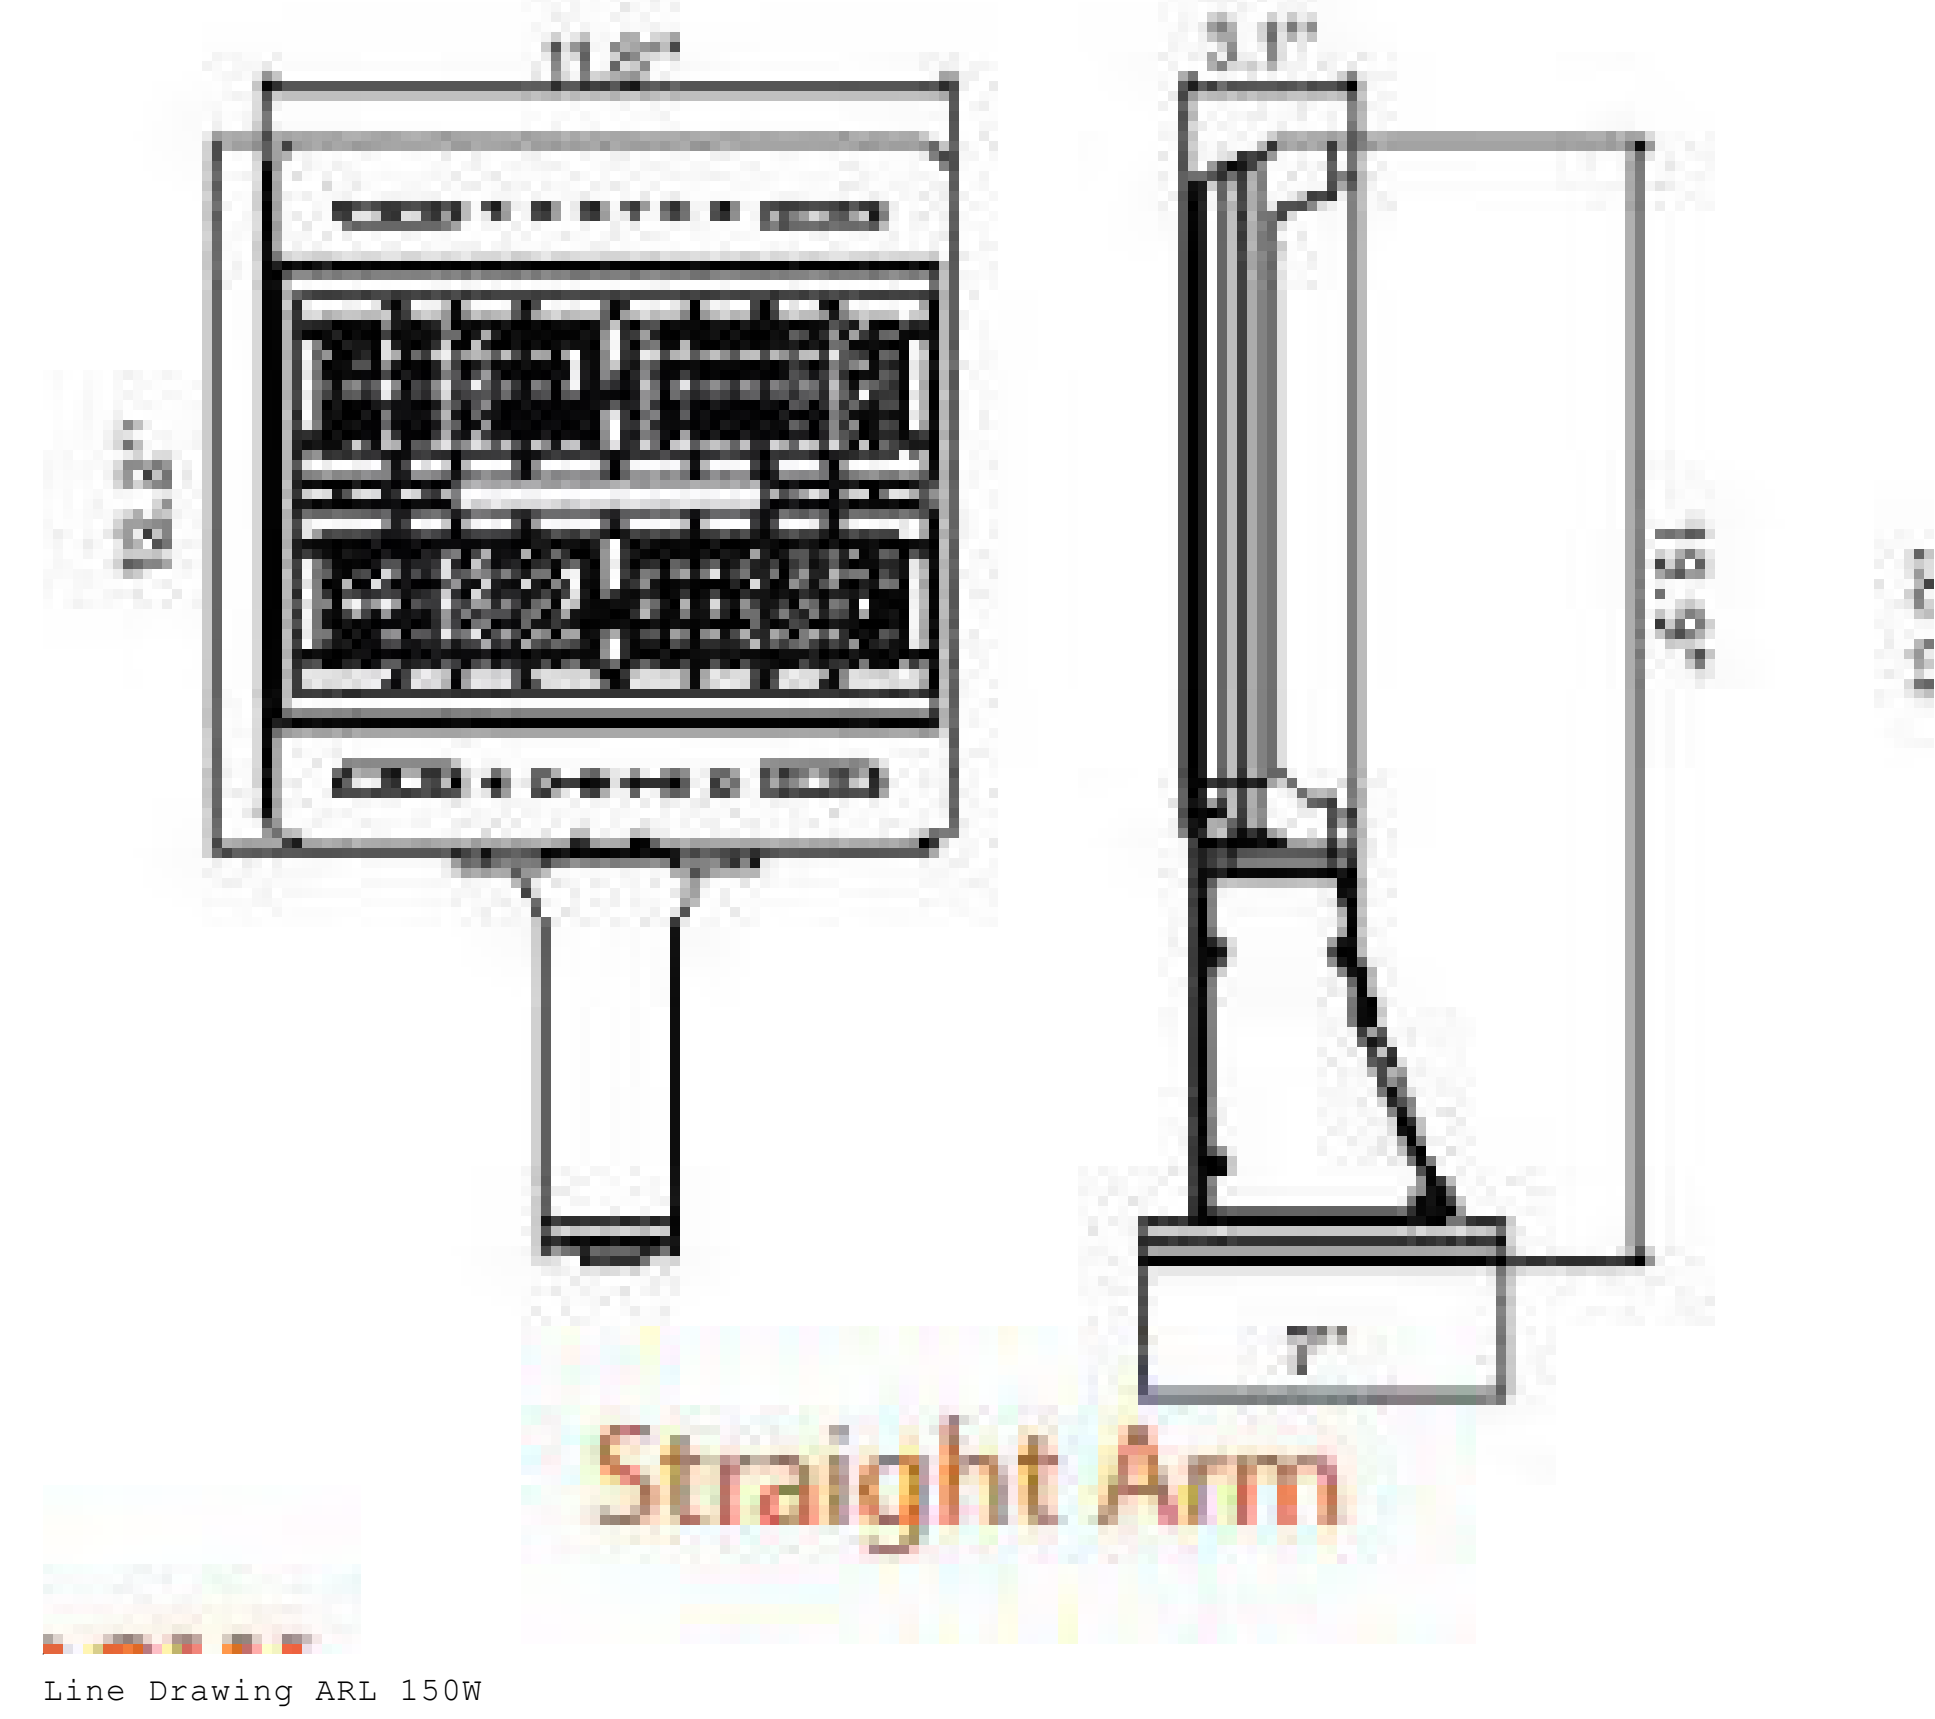

LANGLAIS GROUP INC.
 P.O. BOX 698 ROAD
 SOUTH WINDSOR CT 06074
 PHONE 860-289-2372
 FAX 860-566-2460



| # | Date | Comments |
|---|------|----------|
| | | |
| | | |

Revisions

Drawn By:
 Checked By:
 Date: 5/19/2020

Scale:

LAKESIDE OF CHESHIRE